

 
NOTES :

- WRITTEN DIMENSIONS ON THESE DRAWINGS SHALL HAVE PRECEDENCE OVER SCALED DIMENSIONS.
- CONTRACTOR/SUPPLIER SHALL VERIFY AND BE RESPONSIBLE FOR ALL DIMENSIONS AND CONDITIONS OF THE JOB.
- DISCREPANCIES BETWEEN DRAWINGS AND ACTUAL CONDITION MUST BE IMMEDIATELY FORWARDED TO PMED FOR RESOLUTION.
- SUPPLIER TO SUBMIT SHOP DRAWINGS TO PMED FOR APPROVAL PRIOR TO FABRICATION.
- SUPPLIER TO COORDINATE WITH THE END-USER ON THE SCHEDULE OF MOBILIZATION/DELIVERY OF THE SAID ITEM.




DETAILED ELEVATION

SCALE: L 1:40M



FRONT ELEVATION

SCALE: 200 200 1:100M

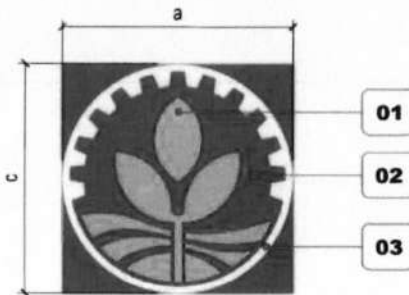

LOGO


SCALE: 1:10M

NOTE: BLACK FILM SHOULD BE INSTALLED/APPLIED AT THE REAR SIDE PORTION/SURFACE OF THE FLEXIBLE SUBSTRATE.

REVISION DATE:

LEGEND		COLOR GUIDE	
a	634 mm	01	GOLD - PANTONE No. 130 C
b	211 mm	02	GREEN - PANTONE No. 355 C
c	3804 mm	03	WHITE - PLAIN SUBSTRATE SURFACE
d	83mm	04	BLACK - PANTONE PROCESS BLACK C
e	160 mm	F O N T T Y P E	
f	423 mm		
H	800 mm	LANDBANK - <u>ARIAL BLACK</u>	
L	SIGNAGE LENGTH	BRANCH NAME - <u>ANTENNA CONDENSED BOLD</u>	
Z	VARIES	NOTE: PROVIDE DIGITAL TIMER SWITCH	
F O R M U L A			
$y = \frac{L - x}{2}$			

Revised Annex D-4

 <p>LAND BANK OF THE PHILIPPINES PROJECT MANAGEMENT & ENGINEERING DEPT. 1598 M.H. DEL PILAR ST., CORNER DR. QUINTOS ST., MALATE, MANILA</p>	<p>TITLE:</p> <p align="center">BRANCH HORIZONTAL SIGNAGE</p>	<p>RECOMMENDING APPROVAL:</p> <p align="center"><i>Enrico D.J. Samaniego</i> ENRICO D.J. SAMANIEGO HEAD, PMED</p>	<p>SHEET CONTENT:</p> <p>FRONT ELEVATION DETAILED ELEVATION LOGO LEGEND FORMULA COLOR GUIDE FONT TYPE NOTE</p>	<p>DESIGN: PMED - TSU</p> <p>DRAWN: A. EBORA</p> <p>DATE: 30-July-2020</p> <p>CHECKED: <i>M. Padua</i> M. PADUA</p> <p>REVIEWED: <i>J. Mislang</i> J. MISLANG</p>	<p>SHEET NO:</p> <p align="center">A 1</p>
	<p>LANDBANK STANDARD DETAILS AND SPECIFICATIONS</p>				


- NOTES:**
- WRITTEN DIMENSIONS ON THESE DRAWINGS SHALL HAVE PRECEDENCE OVER SCALED DIMENSIONS
 - CONTRACTOR/SUPPLIER SHALL VERIFY AND BE RESPONSIBLE FOR ALL DIMENSIONS AND CONDITIONS OF THE JOB
 - DISCREPANCIES BETWEEN DRAWINGS AND ACTUAL CONDITION MUST BE IMMEDIATELY FORWARDED TO PMED FOR RESOLUTION
 - SUPPLIER TO SUBMIT SHOP DRAWINGS TO PMED FOR APPROVAL PRIOR TO FABRICATION
 - SUPPLIER TO COORDINATE WITH THE END-USER ON THE SCHEDULE OF MOBILIZATION/DELIVERY OF THE SAID ITEM

POSITION OF LED LAMPS
(SUPPLIER TO SUBMIT
PREFERRED LIGHTING
LAYOUT FOR APPROVAL)




DETAILED SECTION
SCALE: 1:40 M

SEE BLOW-UP SECTION-1

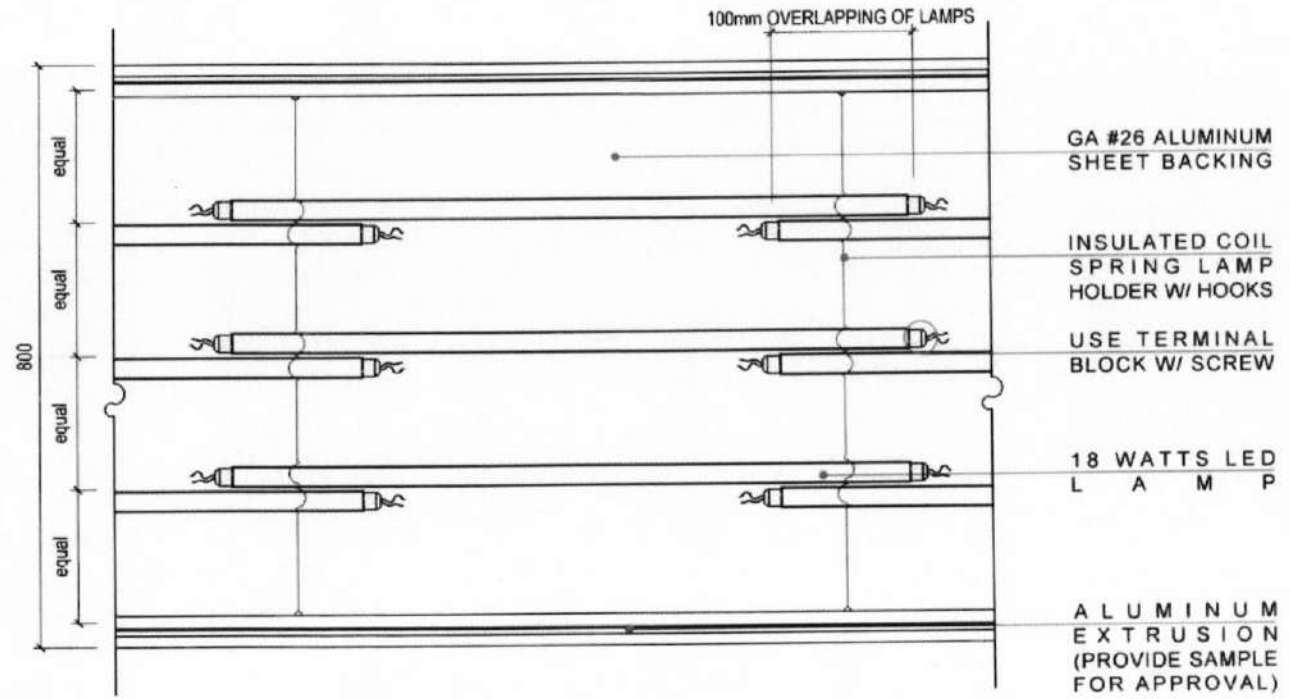

BLOW-UP SECTION-1
SCALE: 1:10 M

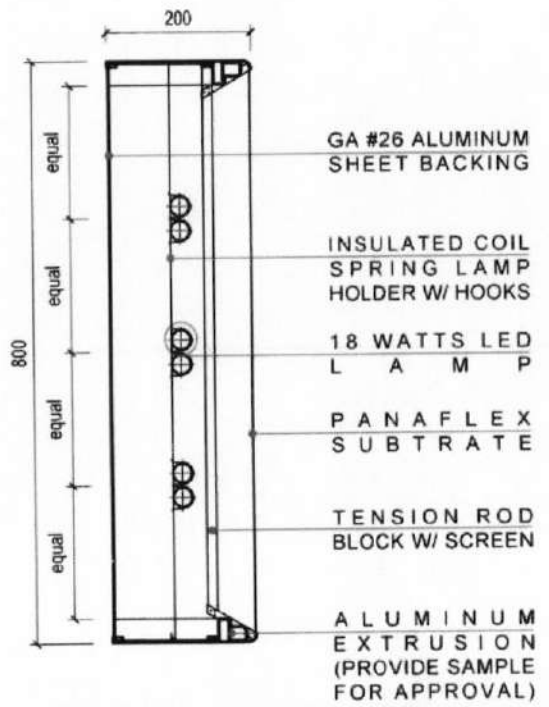

BLOW-UP SECTION-2
SCALE: 1:10 M

Revised AmC/D D-5

REVISION DATE:



LAND BANK OF THE PHILIPPINES
PROJECT MANAGEMENT & ENGINEERING DEPT.
1598 M.H. DEL PILAR ST., CORNER DR. QUINTOS ST., MALATE, MANILA

TITLE:
BRANCH HORIZONTAL SIGNAGE
LANDBANK STANDARD DETAILS AND SPECIFICATIONS

RECOMMENDING APPROVAL:
[Signature]
ENSICO D.J. SAMANIEGO
HEAD, PMED

SHEET CONTENT:
DETAILED SECTION
BLOW-UP SECTION -1
BLOW-UP SECTION 2

DESIGN : PMED - TSU
DRAWN : A. EBORA
DATE : 30-July-2020
CHECKED : *[Signature]* M. PADUA
REVIEWED : *[Signature]* J. MISLANG

SHEET NO:
**A
2**

NOTES:

- WRITTEN DIMENSIONS ON THESE DRAWINGS SHALL HAVE PRECEDENCE OVER SCALED DIMENSIONS.
- CONTRACTOR/SUPPLIER SHALL VERIFY AND BE RESPONSIBLE FOR ALL DIMENSIONS AND CONDITIONS OF THE JOB.
- DISCREPANCIES BETWEEN DRAWINGS AND ACTUAL CONDITION MUST BE IMMEDIATELY FORWARDED TO PMED FOR RESOLUTION
- SUPPLIER TO SUBMIT SHOP DRAWINGS TO PMED FOR APPROVAL PRIOR TO FABRICATION
- SUPPLIER TO COORDINATE WITH THE END-USER ON THE SCHEDULE OF MOBILIZATION/DELIVERY OF THE SAID ITEM

GENERAL NOTES:

- a. Supplier must be an authorized converter of the brand of translucent film and should provide certification from the manufacturer (i.e. 3M or Avery, etc.).
- b. Warranty shall be as follows:
 1. Converter/supplier to submit warranty certificate of 5 years on the translucent film against discoloration/color fading and adhesion.
 2. Converter/supplier to submit warranty certificate of 3 years against any defect in product and workmanship from the converter.
 3. Converter/supplier to submit warranty certificate of 3 years on the flexible substrate against blow-out and mildew resistance.
- c. Graphics cutting of translucent film shall be done with computer cutter (manual cutting shall not be allowed nor accepted).
- d. Flexible substrate and translucent film shall be seamless.
- e. Supplier to submit detailed drawings printed on A4 size paper with the supplier's official letterhead and mock-up unit to PMED for post qualification evaluation.
- f. Written dimension on the drawings shall have precedence over scaled dimensions.
- g. Supplier shall verify and be responsible for all dimensions and conditions of the job.
- h. Discrepancies between drawings and actual condition must be immediately forwarded to PMED for resolution.
- i. Supplier to submit shop drawings to PMED for approval prior to fabrication.
- j. Supplier to coordinate with the end-user on the schedule of mobilization/ delivery of the said item.
- k. Supplier to submit (as part of the documentary requirements) to PMED the photos of actual installed items. (close-up and full view of the said item) for issuance of certificate of satisfactory performance.

SPECIFICATIONS:

I. FLEXIBLE SUBSTRATE

ITEM	DESCRIPTION
Type	White-pigmented cast vinyl fabric with reinforcing polyester scrim, smooth front surface with semi-gloss appearance (dirt resistant front and back)
Weight	650 gsm (minimum)
Thickness	23 mils (minimum) or 584.2 micron

II. TRANSLUCENT STICKERS

ITEM	DESCRIPTION
Type	matte surface translucent cast vinyl films
Thickness	without adhesive - 2 mils (minimum) or 50.8 micron with adhesive - 3 mils (minimum) or 76.20 micron

III. FRAME AND BACKING





ITEM	DESCRIPTION
Type	All-aluminum pre molded extrusion and cover color green (PANTONE 355 C) with aluminum framing and GA. # 26 aluminum sheet backing, stainless steel hinges, and G.I. pipe tension rod (submit sample to PMED for approval before production).

IV. COLOR GUIDE

ITEM	DESCRIPTION
GREEN	PANTONE No. 355 C
GOLD	PANTONE No. 130 C
WHITE	White (plain substrate surface)

Revised Annex D-6


REVISION DATE:

	<p>LAND BANK OF THE PHILIPPINES</p> <p>PROJECT MANAGEMENT & ENGINEERING DEPT.</p> <p>1598 M.H. DEL PILAR ST., CORNER DR. QUINTOS ST., MALATE, MANILA</p>	<p>TITLE:</p> <p style="text-align: center; font-weight: bold; font-size: 1.2em;">BRANCH HORIZONTAL SIGNAGE</p> <p style="text-align: center; font-size: 0.8em;">LANDBANK STANDARD DETAILS AND SPECIFICATIONS</p>	<p>RECOMMENDING APPROVAL:</p> <p style="text-align: center;">  ENRICO D.J. SAMANIEGO <small>HEAD, PMED</small> </p>	<p>SHEET CONTENT:</p> <p style="text-align: center;">GENERAL NOTES SPECIFICATIONS</p>	<p>DESIGN : PMED - TSU</p> <p>DRAWN : A. EBORA</p> <p>DATE : 30-July-2020</p> <p>CHECKED :  M. PADUA</p> <p>REVIEWED :  J. MISLANG</p>	<p>SHEET NO:</p> <div style="border: 2px solid black; border-radius: 50%; width: 40px; height: 40px; margin: 0 auto; display: flex; align-items: center; justify-content: center;"> <div style="text-align: center;"> <p style="font-size: 1.5em; margin: 0;">A</p> <p style="font-size: 2em; margin: 0;">3</p> </div> </div>
	REVISION DATE:					

NOTES:

- WRITTEN DIMENSIONS ON THESE DRAWINGS SHALL HAVE PRECEDENCE OVER SCALED DIMENSIONS.
- CONTRACTOR/SUPPLIER SHALL VERIFY AND BE RESPONSIBLE FOR ALL DIMENSIONS AND CONDITIONS OF THE JOB.
- **PMED** MUST BE NOTIFIED IMMEDIATELY OF ANY VARIATIONS FROM THE DIMENSIONS AND CONDITIONS SHOWN IN THESE DRAWINGS.
- CONTRACTOR/SUPPLIER SHALL SUBMIT SHOP DRAWING AND PROTOTYPE TO **PMED** FOR APPROVAL BEFORE PRODUCTION.

CLASS D

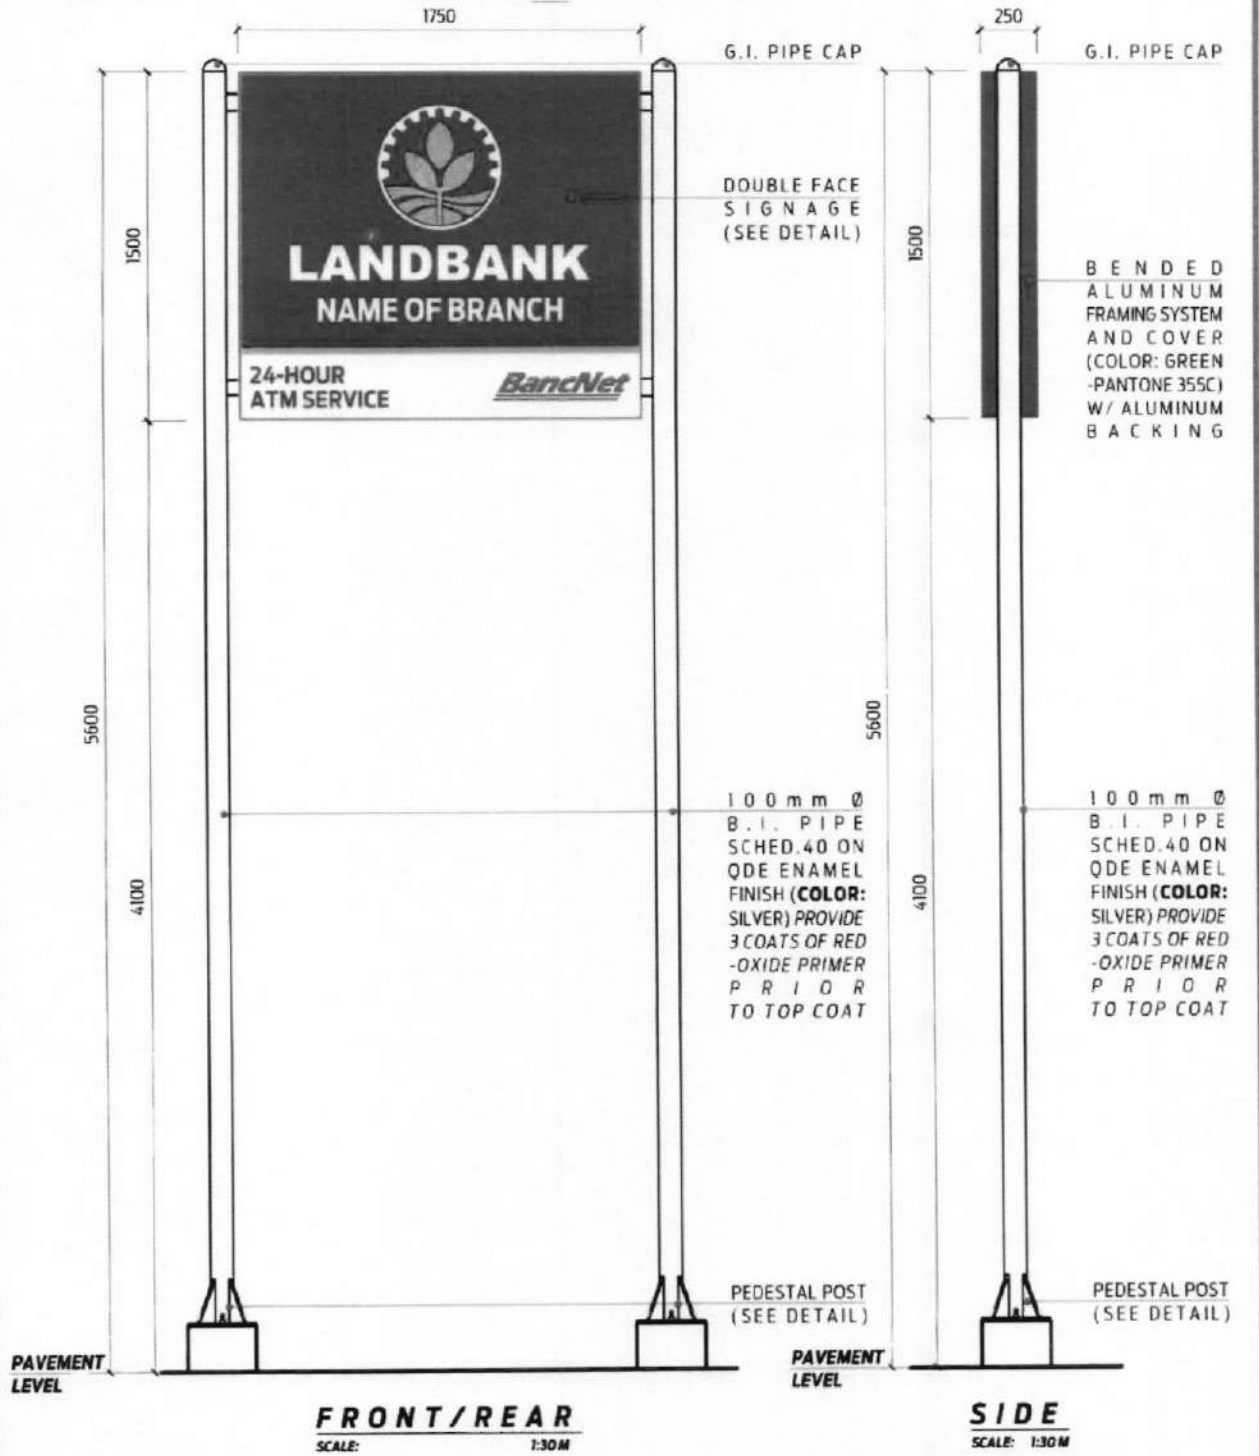


FRONT/REAR

SCALE: 1:30M

SIDE

SCALE: 1:30M


 <p>LAND BANK OF THE PHILIPPINES PROJECT MANAGEMENT & ENGINEERING DEPT. 1501 M.H. DEL PILAR ST., CORNER DR. QUINTOS ST., MALATE, MANILA</p>	<p>TITLE: VERTICAL SIGNAGE LANDBANK STANDARD DETAILS & SPECIFICATIONS</p>		DESIGN: TSU - PMED	SHEET NO:
	<p>RECOMMENDING APPROVAL: <i>Enrico D.J. Samaniego</i> ENRICO D.J. SAMANIEGO HEAD, PMED</p>		DRAWN: A.EBORA	VS-10F5
			DATE: 30-July-2020	
			CHECKED: <i>M. Padua</i> M. PADUA	
			REVIEWED: <i>J. Mislang</i> J. MISLANG	

Revised Annex
D-7

NOTES :

- WRITTEN DIMENSIONS ON THESE DRAWINGS SHALL HAVE PRECEDENCE OVER SCALED DIMENSIONS
- CONTRACTOR/SUPPLIER SHALL VERIFY AND BE RESPONSIBLE FOR ALL DIMENSIONS AND CONDITIONS OF THE JOB.
- **PMED** MUST BE NOTIFIED IMMEDIATELY OF ANY VARIATIONS FROM THE DIMENSIONS AND CONDITIONS SHOWN IN THESE DRAWINGS.
- CONTRACTOR/SUPPLIER SHALL SUBMIT SHOP DRAWING AND PROTOTYPE TO **PMED** FOR APPROVAL BEFORE PRODUCTION.


 


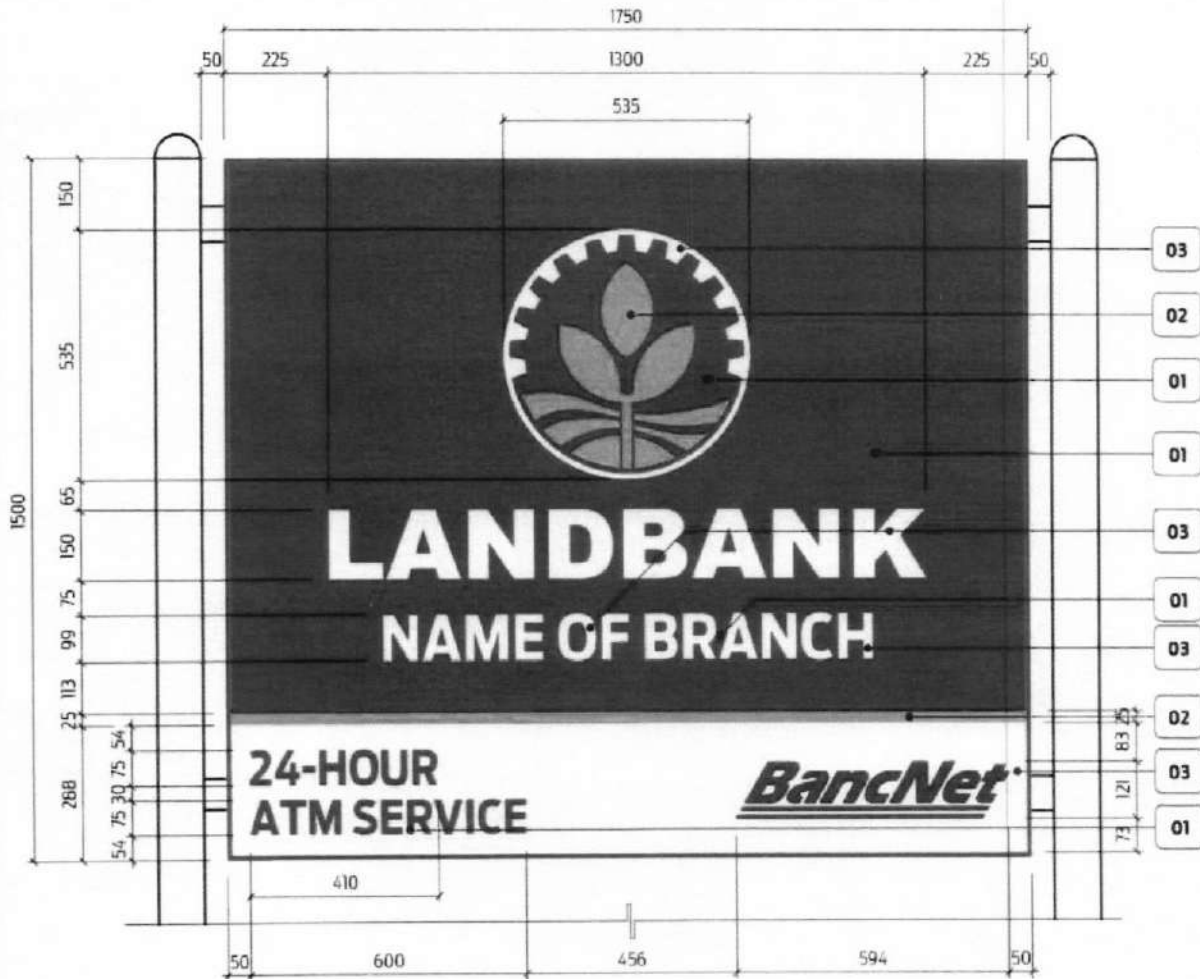CLASS D



DOUBLE FACE

SCALE: 1:15 M

COLOR GUIDE		FONT TYPE
01	GREEN - PANTONE No. 355 C	LANDBANK - <u>ARIAL BLACK</u>
02	GOLD - PANTONE No. 130 C	NAME OF BRANCH - <u>ANTENNA CONDENSED BOLD</u>
03	WHITE - PLAIN SUBSTRATE SURFACE	24-HOUR ATM SERVICE - <u>ANTENNA CONDENSED BOLD</u>
NOTE: <u>PROVIDE DIGITAL TIMER SWITCH</u>		

 <p>LAND BANK OF THE PHILIPPINES PROJECT MANAGEMENT & ENGINEERING DEPT. 1998 M.H. DEL PILAR ST., CORNER DR. QUINTOS ST., MALATE, MANILA</p>	<p>TITLE: VERTICAL SIGNAGE</p> <p>LANDBANK STANDARD DETAILS & SPECIFICATIONS</p> <p>RECOMMENDING APPROVAL:  ENRIGO D.J. SAMANIEGO HEAD, PMED</p>	<p>DESIGN: TSU - PMED</p> <p>DRAWN: A.EBORA</p> <p>DATE: 30-May-2020</p> <p>CHECKED:  M.PADUA</p> <p>REVIEWED:  J.MISLANG</p>	<p>SHEET NO.</p> <p>VS-20F5</p>
---	--	---	--


Revised Annex

D-8


NOTES:

- WRITTEN DIMENSIONS ON THESE DRAWINGS SHALL HAVE PRECEDENCE OVER SCALED DIMENSIONS
- CONTRACTOR/SUPPLIER SHALL VERIFY AND BE RESPONSIBLE FOR ALL DIMENSIONS AND CONDITIONS OF THE JOB
- **PMED** MUST BE NOTIFIED IMMEDIATELY OF ANY VARIATIONS FROM THE DIMENSIONS AND CONDITIONS SHOWN IN THESE DRAWINGS
- CONTRACTOR/SUPPLIER SHALL SUBMIT SHOP DRAWING AND PROTOTYPE TO **PMED** FOR APPROVAL BEFORE PRODUCTION

CLASS D

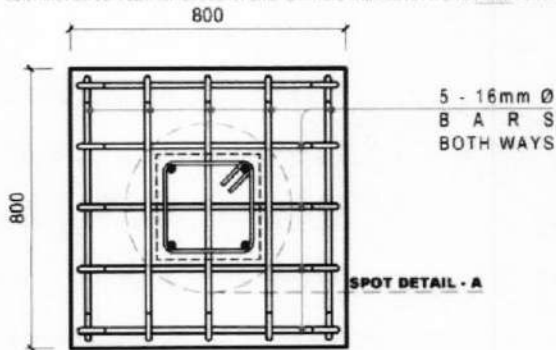


PLAN

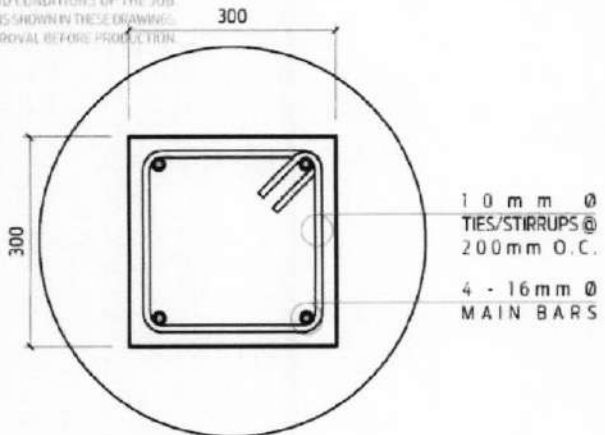

SPOT DETAIL - A

SCALE 1:10M


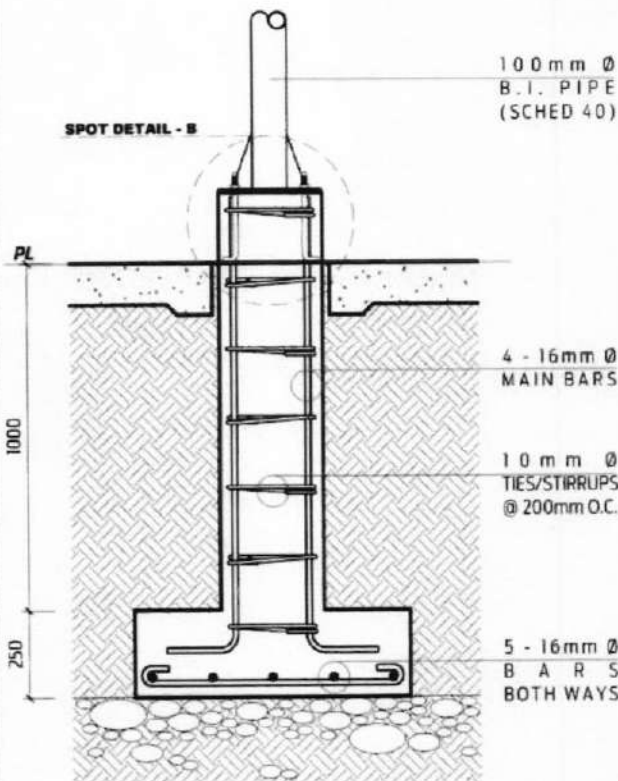


SECTION

DETAIL OF PEDESTAL POST

SCALE 1:20M

NOTE: ALL EXPOSED METAL SURFACE (B.I. PIPES/M.S. PLATES/BOLTS) SHALL BE PAINTED WITH QDE ENAMEL FINISH (COLOR: SILVER) PROVIDE 3 COATS OF RED -OXIDE PRIMER PRIOR TO TOP COAT ALL WELDED CONNECTIONS MUST BE FULL-WELD WITH E70-J1.

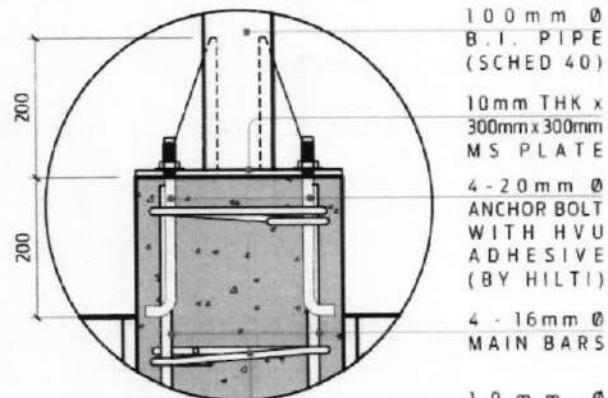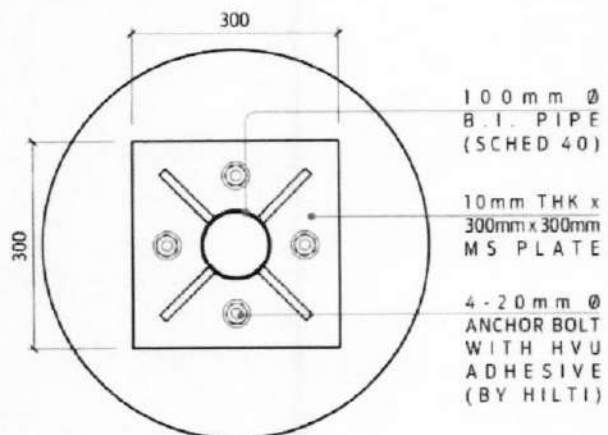

SPOT DETAIL - B

SCALE 1:10M



LAND BANK OF THE PHILIPPINES
PROJECT MANAGEMENT & ENGINEERING DEPT.

1098 M.H. DEL PILAR ST., CORNER DR. QUINTOS ST., MALATE, MANILA

TITLE: **VERTICAL SIGNAGE**
LANDBANK STANDARD DETAILS & SPECIFICATIONS

RECOMMENDING APPROVAL:
Enrico B. Samaniego
ENRICO B. SAMANIEGO
HEAD, PMED


DESIGN: TSU-PMED
DRAWN: ALEGORA
DATE: 30-July-2020
CHECKED: M.PADUA
REVIEWED: J.MISLANG

SHEET NO:
VS-30F5


NOTES :

- WRITTEN DIMENSIONS ON THESE DRAWINGS SHALL HAVE PRECEDENCE OVER SCALED DIMENSIONS.
- CONTRACTOR/SUPPLIER SHALL VERIFY AND BE RESPONSIBLE FOR ALL DIMENSIONS AND CONDITIONS OF THE JOB.
- **PMED** MUST BE NOTIFIED IMMEDIATELY OF ANY VARIATIONS FROM THE DIMENSIONS AND CONDITIONS SHOWN IN THESE DRAWINGS.
- CONTRACTOR/SUPPLIER SHALL SUBMIT SHOP DRAWING AND PROTOTYPE TO **PMED** FOR APPROVAL BEFORE PRODUCTION.


CLASS D

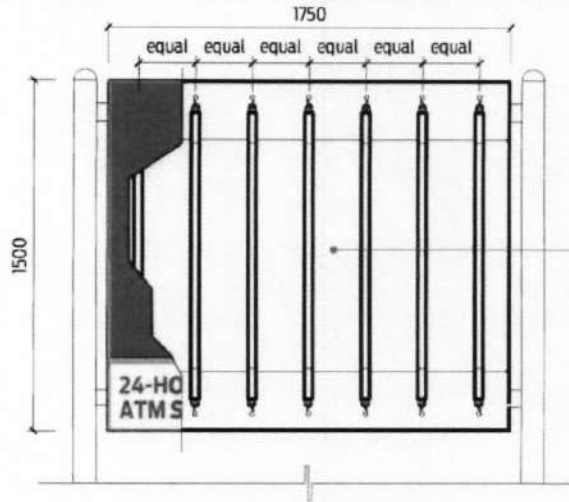

POSITION OF LED LAMPS
(SUPPLIER TO SUBMIT PREFERRED
LIGHTING LAYOUT FOR APPROVAL
PRIOR TO FABRICATION)

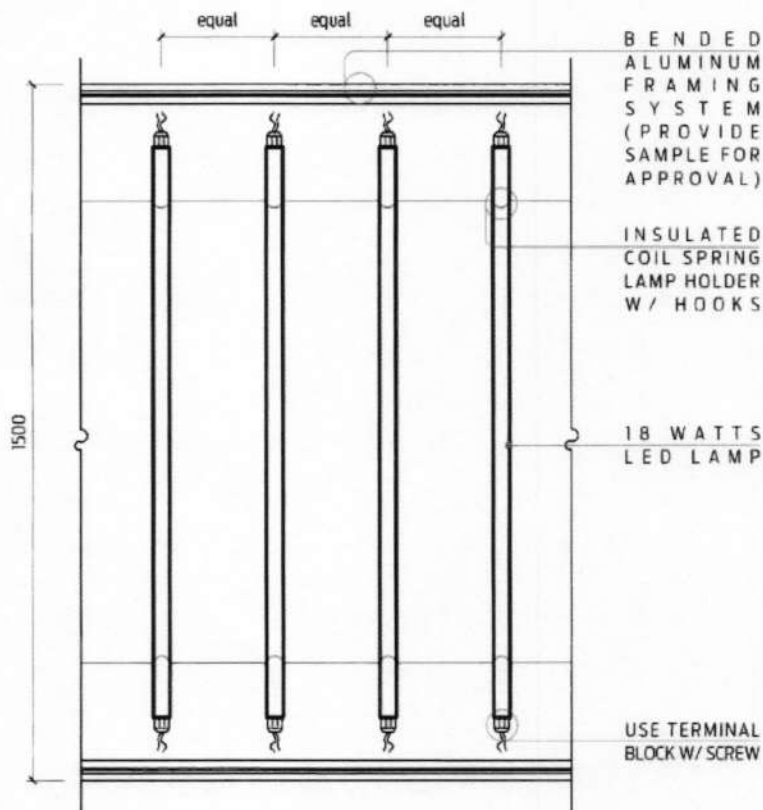

SECTION - A

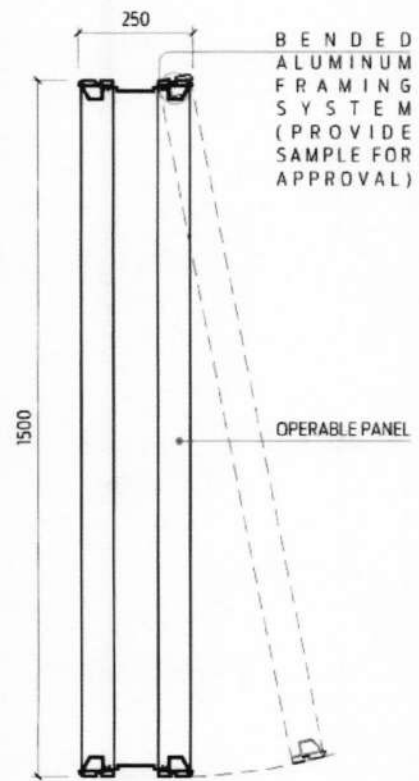

SECTION - B

LIGHTING DETAIL

SCALE 1:15M



LAND BANK OF THE PHILIPPINES
PROJECT MANAGEMENT & ENGINEERING DEPT.

1596 M.H. DEL PILAR ST., CORNER DR. QUINTOS ST., MALATE, MANILA

TITLE:
VERTICAL SIGNAGE

LANDBANK STANDARD DETAILS & SPECIFICATIONS

RECOMMENDING APPROVAL:
Enrico D. Samaniego
ENRICO D. SAMANIEGO
HEAD, PMED

DESIGN: TSU - PMED

DRAWN: A.EBORA

DATE: 30-July-2020

CHECKED: M.PADUA

REVIEWED: J.MISLANG

SHEET NO:

VS-4 OF 5

GENERAL NOTES:

CLASS D

- a. Supplier must be an authorized converter of the brand of translucent film and should provide certification from the manufacturer (i.e. 3M or Avery, etc.)
- b. Warranty shall be as follows.
 - 1. Converter/ supplier to submit warranty certificate of 5 years on the translucent film against discoloration/color fading and adhesion.
 - 2. Converter/ supplier to submit warranty certificate of 3 years against any defect in product and workmanship from the converter.
 - 3. Converter/supplier to submit warranty certificate of 3 years on the flexible substrate against blow-out and mildew resistance.
- c. Graphics cutting of translucent film shall be done with computer cutter (manual cutting shall not be allowed nor accepted).
- d. Flexible substrate and translucent film shall be seamless.
- e. Supplier to submit detailed drawings printed on A4 size paper with the supplier's official letterhead and mock-up unit to pmed for post qualification evaluation.
- f. Written dimension on the drawings shall have precedence over scaled dimensions.
- g. Supplier shall verify and be responsible for all dimensions and conditions of the job.
- h. Discrepancies between drawings and actual condition must be immediately forwarded to PMED for resolution.
- i. Supplier to submit shop drawings to PMED for approval prior to fabrication.
- j. Supplier to coordinate with the end-user on the schedule of mobilization/ delivery of the said item.
- k. Supplier to submit (as part of the documentary requirements) to PMED the photos of actual installed items. (close-up and full view of the said item) for issuance of certificate of satisfactory performance.

SPECIFICATIONS:

I. TRANSLUCENT STICKERS

ITEM	DESCRIPTION
Type	matte surface translucent cast vinyl films
Thickness	without adhesive - 2 mils (minimum) or 50.8 micron with adhesive - 3 mils (minimum) or 76.20 micron

II. FRAME, BACKING & STAND

ITEM	DESCRIPTION
Frame and Backing	Bended aluminum framing system and cover (color: green -pantone 355c) w/ aluminum backing
Frame support and Stand	100mm Ø B.I. pipe on QDE enamel finish for frame support and 150mm Ø B.I. pipe on QDE enamel finish for stand with G.I. pipe cap (color: silver) provide 3 coats of red -oxide primer prior to top coat

III. COLOR GUIDE


 


ITEM	DESCRIPTION
GREEN	PANTONE No. 355 C
GOLD	PANTONE No. 130 C
WHITE	White (plain substrate surface)

IV. LIGHTING SYSTEM

ITEM	DESCRIPTION
LED	18 watts LED lamp


V. DIGITAL TIMER SWITCH

DIGITAL TIMER SWITCH	
Rated voltage :	230 - 240 VAC
Frequency :	50 to 60 Hz
Contact Materials :	Ag Sn O2 (Silver Tin Dioxide)
Switching Power :	16 Amp 250 VAC
Timing Basis :	Quartz
Shortest Switching Time :	1 minute
Operating Time/Period Setting :	6:00pm-10:00pm
Switching Precision :	Exact to the second
Display :	LCD display with text line
Power Reserve :	With approx. 4 yrs with display
Permissible Amb. Temp. :	-10°C to 50°C
Weight :	150g - 180g


 <p>LAND BANK OF THE PHILIPPINES PROJECT MANAGEMENT & ENGINEERING DEPT. 1699 M.H. DEL PILAR ST., CORNER DR. QUINTOS ST., MALATE, MANILA</p>	<p>TITLE: VERTICAL SIGNAGE</p> <p>LANDBANK STANDARD DETAILS & SPECIFICATIONS</p> <p>RECOMMENDING APPROVAL:  ENRICO O. SAMANIEGO HEAD, PMED</p>	<p>DESIGN: TSU - PMED</p> <p>DRAWN: AEBORA</p> <p>DATE: 30 July 2020</p> <p>CHECKED:  MPADUA</p> <p>REVIEWED:  J.MISLANG</p>	<p>SHEET NO:</p> <p>VS-5 OF 5</p>
--	---	--	--

NOTES:


- WRITTEN DIMENSIONS ON THESE DRAWINGS SHALL HAVE PRECEDENCE OVER SCALED DIMENSIONS.
- CONTRACTOR/SUPPLIER SHALL VERIFY AND BE RESPONSIBLE FOR ALL DIMENSIONS AND CONDITIONS OF THE JOB
- DISCREPANCIES BETWEEN DRAWINGS AND ACTUAL CONDITION MUST BE IMMEDIATELY FORWARDED TO PMED FOR RESOLUTION.
- SUPPLIER TO SUBMIT SHOP DRAWINGS TO PMED FOR APPROVAL PRIOR TO FABRICATION.
- SUPPLIER TO COORDINATE WITH THE END-USER ON THE SCHEDULE OF MOBILIZATION/DELIVERY OF THE SAID ITEM.

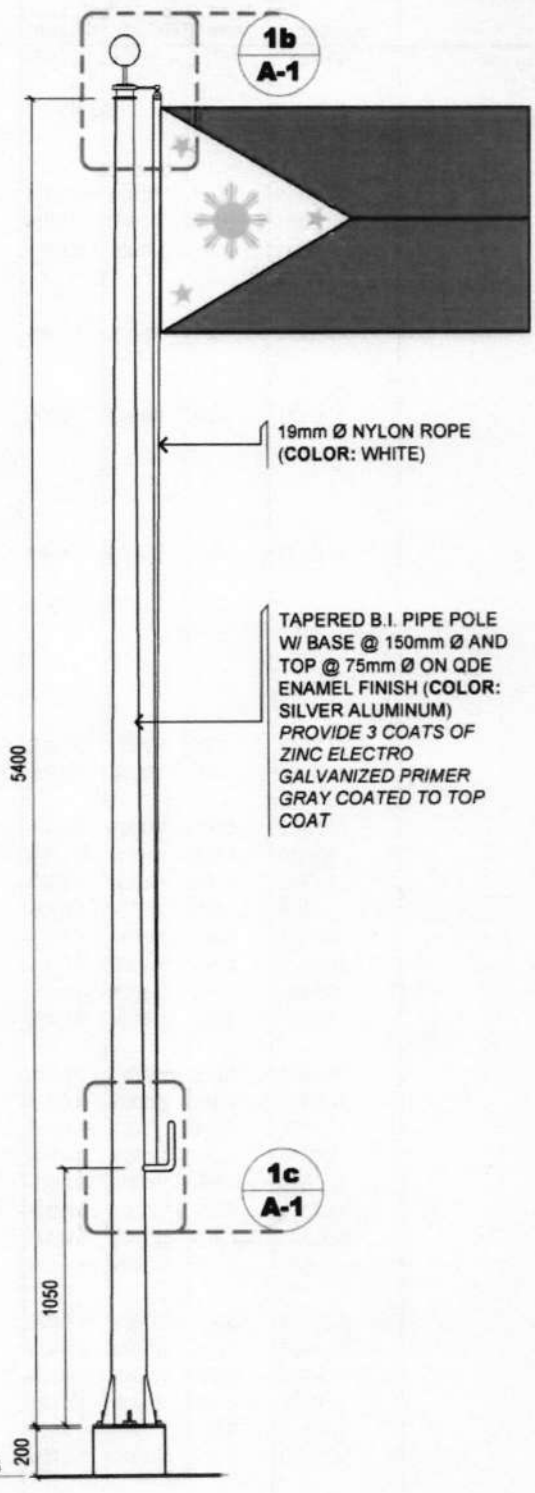


1a DETAILED ELEVATION
SCALE 1:30 METERS

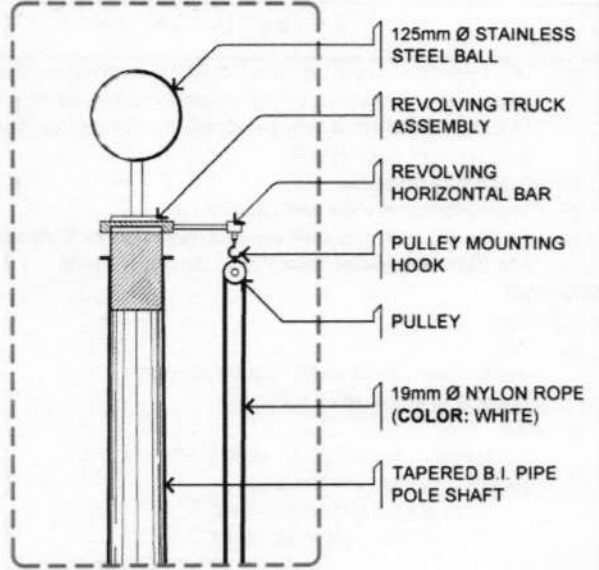

1b SPOT DETAIL - A
SCALE 1:10 METERS

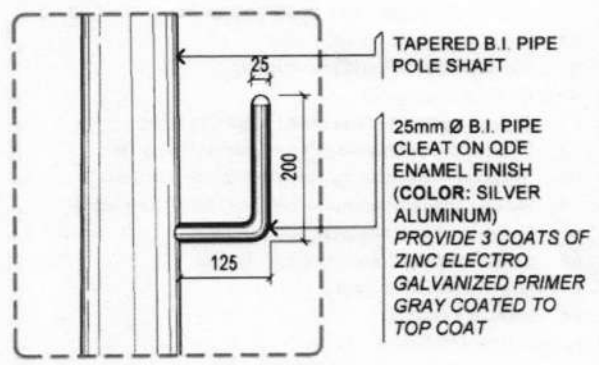

1c SPOT DETAIL - B
SCALE 1:10 METERS

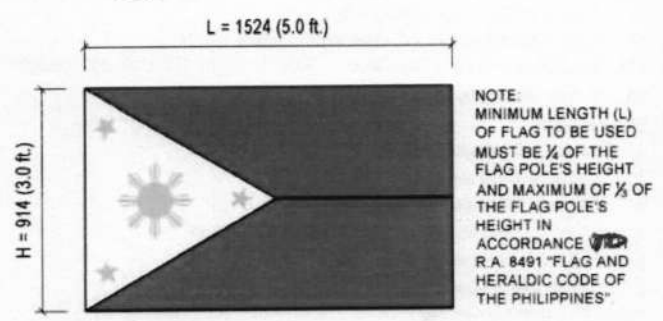

FLAG DIMENSION
SCALE 1:30 M

NOTE:
MINIMUM LENGTH (L) OF FLAG TO BE USED MUST BE 1/4 OF THE FLAG POLE'S HEIGHT AND MAXIMUM OF 1/2 OF THE FLAG POLE'S HEIGHT IN ACCORDANCE WITH R.A. 8491 "FLAG AND HERALDIC CODE OF THE PHILIPPINES".





1 DETAIL OF FLAG POLE
A-1

REVISION DATE:

<p>LANDBANK OF THE PHILIPPINES PROJECT MANAGEMENT & ENGINEERING DEPT. 1598 M.H. DEL PILAR ST., CORNER DR. QUINTOS ST., MALATE, MANILA</p>	<p>TITLE: FLAG POLE</p> <p>LANDBANK STANDARD DETAILS AND SPECIFICATIONS</p> <p>APPROVED BY: <i>Alexander S. Lazaro</i> ALEXANDER S. LAZARO HEAD, PMED</p>	<p>DESIGN: PMED</p> <p>DRAWN: ANNA</p> <p>DATE: 09/02/2019</p> <p>CHECKED: <i>[Signature]</i></p> <p>DATE:</p>	<p>SHEET NO:</p> <p>A 1</p>
	<p>Revised Annex D-12</p>		



NOTES:

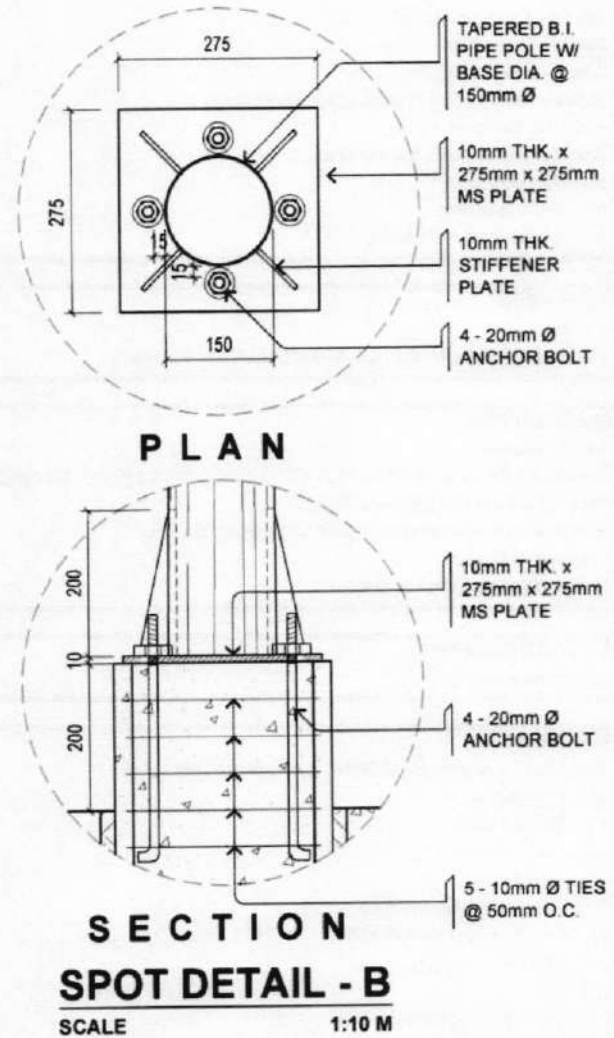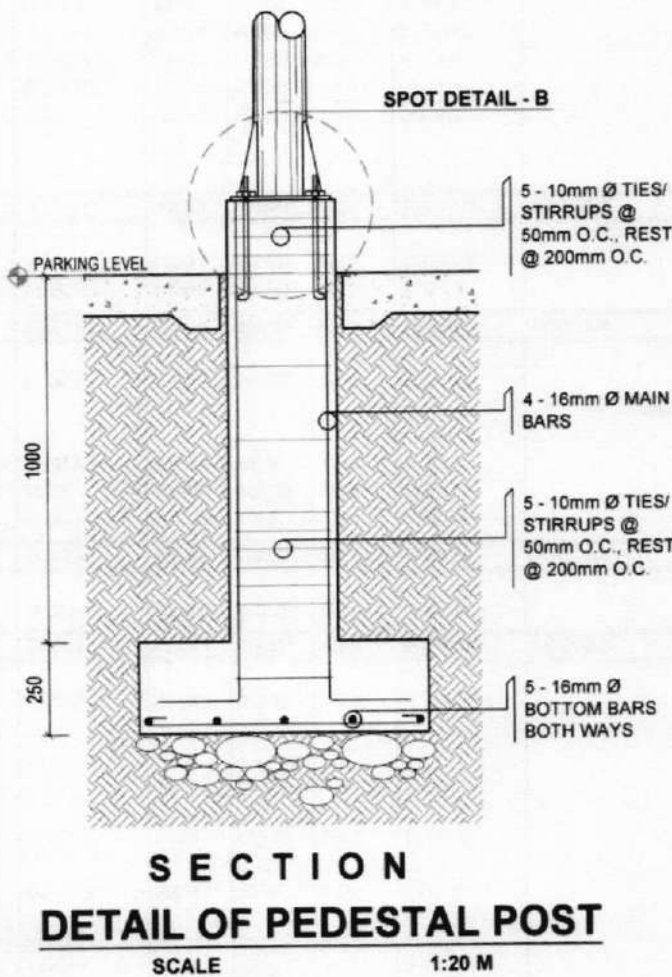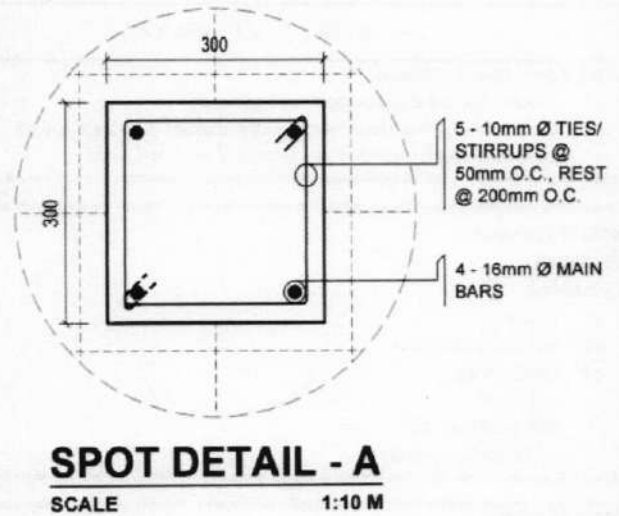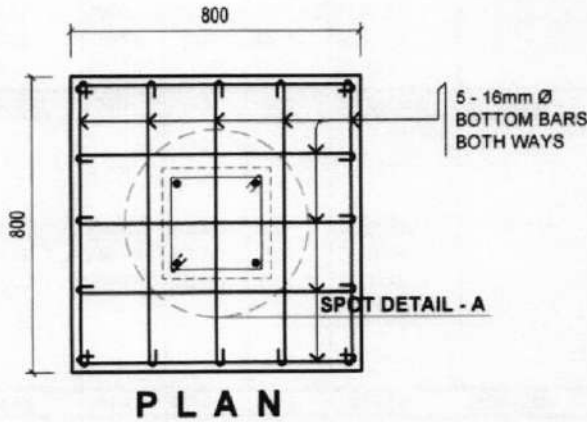- WRITTEN DIMENSIONS ON THESE DRAWINGS SHALL HAVE PRECEDENCE OVER SCALED DIMENSIONS
- CONTRACTOR/SUPPLIER SHALL VERIFY AND BE RESPONSIBLE FOR ALL DIMENSIONS AND CONDITIONS OF THE JOB
- DISCREPANCIES BETWEEN DRAWINGS AND ACTUAL CONDITION MUST BE IMMEDIATELY FORWARDED TO PMED FOR RESOLUTION
- SUPPLIER TO SUBMIT SHOP DRAWINGS TO PMED FOR APPROVAL PRIOR TO FABRICATION
- SUPPLIER TO COORDINATE WITH THE END-USER ON THE SCHEDULE OF MOBILIZATION/DELIVERY OF THE SAID ITEM



NOTE: ALL EXPOSED METAL SURFACE (B.I. PIPES/ M.S. PLATES/ BOLTS) SHALL BE PAINTED WITH QDE ENAMEL FINISH (COLOR: SILVER ALUMINUM) PROVIDE 3 COATS OF ZINC ELECTRO GALVANIZED PRIMER GRAY COATED TO TOP COAT

REVISION DATE:

 <p>LANDBANK OF THE PHILIPPINES PROJECT MANAGEMENT & ENGINEERING DEPT 1598 M.H. DEL PILAR ST., CORNER DR. QUINTOS ST. MALATE, MANILA</p>	TITLE:	DESIGN:	PMED	SHEET NO.:
	FLAG POLE	DRAWN:	ANNA	
	LANDBANK STANDARD DETAILS AND SPECIFICATIONS	DATE:	09/02/2019	
	APPROVED BY:	CHECKED:		
ALEXANDER S. LAZARO HEAD, PMED	DATE:	5/4/19		

CLASS D

COLOR GUIDE

GREEN VIVID GREEN (PANTONE NO 355C)
 WHITE WHITE (PANTONE NO. 11-06 TCX)

FONT GUIDE

LANDBANK	ARIAL BOLD	50mm
ATM	ANTENNA CONDENSED BOLD	70mm
24-HOUR SERVICE	ANTENNA CONDENSED BOLD	25mm
www.landbank.com	ANTENNA CONDENSED BOLD	25mm


DESCRIPTION/ SPECIFICATION

- 01- BASE PANEL- REVERSED DIGITAL STICKER MOUNTED ON 12mm THK. CLEAR ACRYLIC PANEL
- 02- FRAME PANEL- 12mm THK PAINTED (COLOR: VIVID GREEN) WITH WHITE COMPUTER CUT-OUT LETTERS.
- 03- LOGO'S- DIGITAL COLORED PRINTING ON STICKERS
- 04- 1.1M LED STRIP LIGHT MODULE (COOL WHITE, 0.24 WATTS, 12V DC) COMPLETE WITH POWER ADAPTER FOR 230V AC SUPPLY
- 05- LED LIGHT FRAME- 2mm THK, 25mm X 25mm ALUMINUM ANGULAR BAR RUBBER LISO AND SILICON SEALANT PAINTED (VIVID GREEN)
- 06- STEEL FRAME SUPPORT- 3mm THK, 25mm X 25mm B.I. ANGULAR BAR AND 3mm THK X 12mm FLAT BAR WITH RUBBER LISO AND SILICON SEALANT PAINTED (VIVID GREEN)
- 07- FOUR (4) PEG SCREWS AND SCREW CAPS (2 PER SIDE) 15X40MM
- 08- EXISTING WALL OR WINDOW

NOTE:

-SUPPLIER SHALL SUBMIT DETAILED DRAWINGS OF CONNECTION FOR APPROVAL

-PROVIDE PHOTO SENSOR

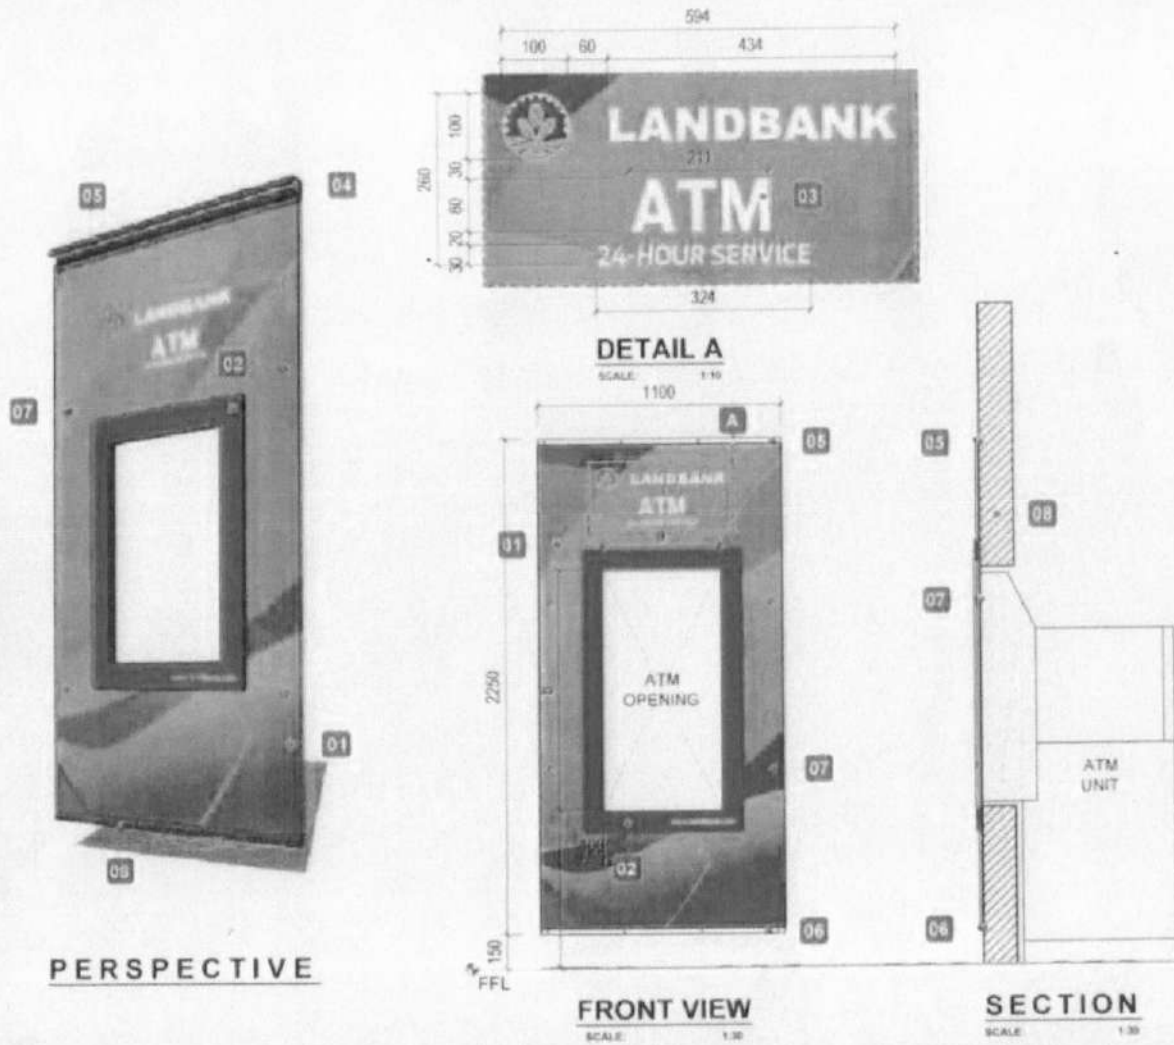

Revised Annex D-17



LANDBANK OF THE PHILIPPINES
 PROJECT MANAGEMENT & ENGINEERING DEPT.
 1398 N.H. DEL PILAR ST., CORNER DR. QUINTOS ST. MALATE, MANILA

PROJECT TITLE:
**ATM THRU THE WALL
 ACRYLIC FRAME PANEL SIGNAGE**
 LANDBANK STANDARD DETAILS AND SPECIFICATIONS


APPROVED BY:

ENRIGO D.J. SAMANIEGO
 HEAD, PRED

SHEET CONTENT:
 PERSPECTIVE
 ELEVATIONS
 SPECIFICATIONS
 COLOR GUIDE
 FONT GUIDE

DESIGN:	PRED-TSU
DRAWN:	MARSON
DATE:	18 NOVEMBER 2010
CHECKED:	J. MISLANG
REV. DATE:	18 MAY 2011

SHEET NO:
A-1
 1.5A.01

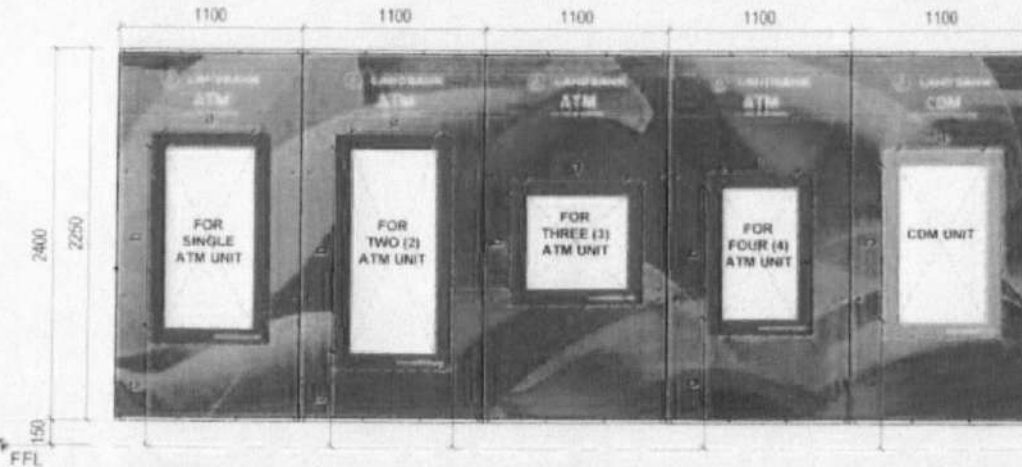

NOTES:

-BACKDROP LAYOUT SHOULD BE CONTINUOUS, DEPENDS ON THE NO. OF ATM & CDM UNIT

-LOGO'S MUST BE ALIGN TOGETHER WITH SIGNAGE BESIDE IT.

SCHEDULE OF CLEARANCE PER TYPE OF ATM & CDM UNIT

DESCRIPTION	a (width of atm opening)	b (height of atm opening)	c (ht of atm opening from fl)
DIEBOLD 560	521mm	940mm	776mm
DIEBOLD 569	444mm	785mm	785mm
DIEBOLD 562/562c/512	430mm	785mm	797mm
PROCASH 285	600mm	560mm	965mm
NCR SELF SERVE 22e	600mm	1000mm	610mm
PROCASH 280 (2017)	510mm	1270mm	570mm
DN PROCASH 280 (2018)	520mm	1090mm	715mm

NOTE:

VERIFY ATM UNIT PRIOR TO IMPLEMENTATION OF ATM OPENING.

CLASS D

**ATM TTW-AFP SIGNAGE
GENERAL NOTES/ TERMS OF REFERENCE:**

- a. SUPPLIER MUST BE AN AUTHORIZED CONVERTER OF THE BRAND OF TRANSLUCENT FILM AND SHOULD PROVIDE CERTIFICATION FROM THE MANUFACTURER (I.E. 3M OR AVERY, ETC.)
- b. SUPPLIER TO SUBMIT WARRANTY CERTIFICATE FOR 3 YEARS FOR THE ITEM
- c. APPLICATION OF TRANSLUCENT FILM TO ACRYLIC SHEET SURFACE SHALL BE SEAMLESS.
- d. SUPPLIER TO SUBMIT DETAILED DRAWINGS PRINTED ON A4 SIZE PAPER WITH THE SUPPLIER'S OFFICIAL LETTERHEAD AND MOCK-UP UNIT TO PMED FOR POST QUALIFICATION EVALUATION
- e. WRITTEN DIMENSION ON THE DRAWINGS SHALL HAVE PRECEDENCE OVER SCALED DIMENSIONS
- f. SUPPLIER SHALL VERIFY AND BE RESPONSIBLE FOR ALL DIMENSIONS AND CONDITIONS OF THE JOB
- g. DISCREPANCIES BETWEEN DRAWINGS AND ACTUAL CONDITION MUST BE IMMEDIATELY FORWARDED TO PMED FOR RESOLUTION
- h. SUPPLIER TO SUBMIT SHOP DRAWINGS TO PMED FOR APPROVAL PRIOR TO FABRICATION.
- i. SUPPLIER TO COORDINATE WITH THE END-USER ON THE SCHEDULE OF MOBILIZATION/ DELIVERY OF THE SAID ITEM
- j. SUPPLIER TO SUBMIT (AS PART OF THE DOCUMENTARY REQUIREMENTS) TO PMED THE PHOTOS OF ACTUAL INSTALLED ITEMS. (CLOSE-UP AND FULL VIEW OF THE SAID ITEM)

Revised Annex D-15

 <p>LANDBANK OF THE PHILIPPINES PROJECT MANAGEMENT & ENGINEERING DEPT. 1588 M.H. DEL PILAR ST., CORNER OR QUINTOS ST., MALATE, MANILA</p>	PROJECT TITLE: ATM THRU THE WALL ACRYLIC FRAME PANEL SIGNAGE	APPROVED BY:  ENRICO D.J. SAMANIEGO HEAD, PMED	SHEET CONTENT: DETAILS GENERAL NOTES	DESIGN: PMED-TM2 DRAWN: MARSON DATE: 06 SEPTEMBER 2018 CHECKED: J. MISLANG REV. DATE: 16 MAY 2019	<p>SHEET NO: A-2 1.SA-01</p>
	LANDBANK STANDARD DETAILS AND SPECIFICATIONS				

CLASS D

COLOR GUIDE

GOLD LEMONGOLD (PANTONE NO.130C)
 WHITE WHITE (PANTONE NO. 11-06 TCX)

FONT GUIDE

LANDBANK ARIAL BOLD 50mm
 CDM ANTENNA CONDENSED BOLD 70mm
 24-HOUR SERVICE ANTENNA CONDENSED BOLD 25mm
 www.landbank.com ANTENNA CONDENSED BOLD 25mm

DESCRIPTION/ SPECIFICATION

- 01- BASE PANEL- REVERSED DIGITAL STICKER MOUNTED ON 12mm THK CLEAR ACRYLIC PANEL
- 02- FRAME PANEL- 12mm THK PAINTED (COLOR LEMONGOLD) WITH WHITE COMPUTER CUT-OUT LETTERS
- 03- LOGO'S- DIGITAL COLORED PRINTING ON STICKERS
- 04- 1.1M LED STRIP LIGHT MODULE (COOL WHITE 0.24 WATTS, 12V DC) COMPLETE WITH POWER ADAPTER FOR 230V AC SUPPLY
- 06- LED LIGHT FRAME- 2mm THK 25mm X 25mm ALUMINUM ANGULAR BAR RUBBER LISO AND SILICON SEALANT PAINTED (VIVID GREEN).
- 06- STEEL FRAME SUPPORT- 3mm THK 25mm X 25mm B1 ANGULAR BAR AND 3mm THK X 12mm FLAT BAR WITH RUBBER LISO AND SILICON SEALANT PAINTED (VIVID GREEN)
- 07- FOUR (4) PEG SCREWS AND SCREW CAPS (2 PER SIDE), 15X40MM
- 08- EXISTING WALL

NOTE:
 -SUPPLIER SHALL SUBMIT DETAILED DRAWINGS OF CONNECTION FOR APPROVAL
 -PROVIDE PHOTO SENSOR



PERSPECTIVE

FRONT VIEW
 SCALE: 1:30

SECTION
 SCALE: 1:30

PROJECT TITLE

**CDM THRU THE WALL
 ACRYLIC FRAME PANEL SIGNAGE**

LANDBANK STANDARD DETAILS AND SPECIFICATIONS

SHEET CONTENT:

PERSPECTIVE
 ELEVATIONS
 SPECIFICATIONS
 COLOR GUIDE
 FONT GUIDE

DESIGN:

DESIGNER: MARRON

DATE: 15 NOVEMBER 2015

CHECKED: A. MERRANO

REV. DATE: 15 MAY 2019

SHEET NO.

A-1

1 OF 01



LANDBANK OF THE PHILIPPINES
 PROJECT MANAGEMENT & ENGINEERING DEPT
 1188 M.H. DEL PILAR ST. CORNER DR. SURTOS ST. BALATE
 MANDALAY CITY


APPROVED BY:

Enrico D.J. Samaniego
 ENRICO D.J. SAMANIEGO
 HEAD, PIED

CLASS D

**ATM TTW-AFP SIGNAGE
GENERAL NOTES/ TERMS OF REFERENCE:**

- a. SUPPLIER MUST BE AN AUTHORIZED CONVERTER OF THE BRAND OF TRANSLUCENT FILM AND SHOULD PROVIDE CERTIFICATION FROM THE MANUFACTURER (I.E. 3M OR AVERY, ETC.)
- b. SUPPLIER TO SUBMIT WARRANTY CERTIFICATE FOR 3 YEARS FOR THE ITEM
- c. APPLICATION OF TRANSLUCENT FILM TO ACRYLIC SHEET SURFACE SHALL BE SEAMLESS.
- d. SUPPLIER TO SUBMIT DETAILED DRAWINGS, PRINTED ON A4 SIZE PAPER WITH THE SUPPLIER'S OFFICIAL LETTERHEAD AND MOCK-UP UNIT TO PMED FOR POST QUALIFICATION EVALUATION
- e. WRITTEN DIMENSION ON THE DRAWINGS SHALL HAVE PRECEDENCE OVER SCALED DIMENSIONS.
- f. SUPPLIER SHALL VERIFY AND BE RESPONSIBLE FOR ALL DIMENSIONS AND CONDITIONS OF THE JOB
- g. DISCREPANCIES BETWEEN DRAWINGS AND ACTUAL CONDITION MUST BE IMMEDIATELY FORWARDED TO PMED FOR RESOLUTION
- h. SUPPLIER TO SUBMIT SHOP DRAWINGS TO PMED FOR APPROVAL PRIOR TO FABRICATION
- i. SUPPLIER TO COORDINATE WITH THE END-USER ON THE SCHEDULE OF MOBILIZATION/ DELIVERY OF THE SAID ITEM
- j. SUPPLIER TO SUBMIT (AS PART OF THE DOCUMENTARY REQUIREMENTS) TO PMED THE PHOTOS OF ACTUAL INSTALLED ITEMS (CLOSE-UP AND FULL VIEW OF THE SAID ITEM)

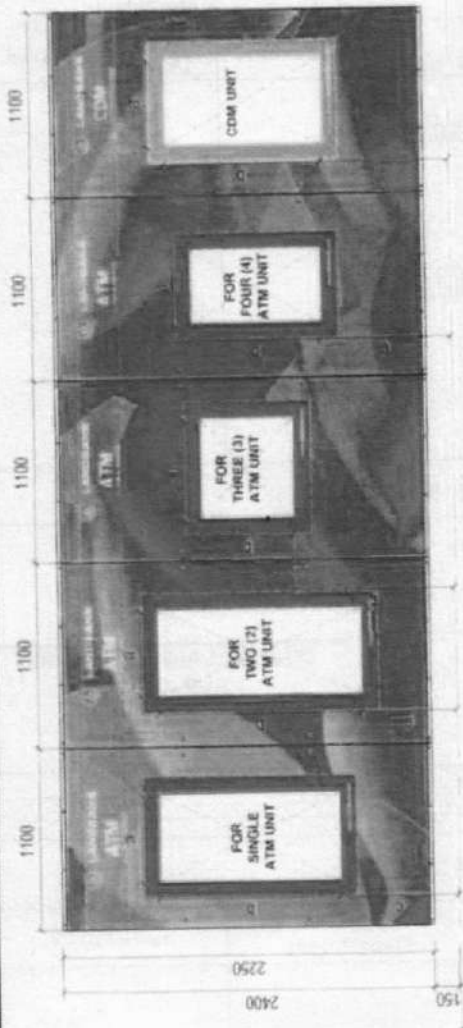

NOTES:
 -BACKDROP LAYOUT SHOULD BE CONTINUES, DEPENDS ON THE NO. OF ATM & CDM UNIT.
 -LOGO'S MUST BE ALIGN TOGETHER WITH SIGNAGE BESIDE IT.

SCHEDULE OF CLEARANCE PER TYPE OF ATM & CDM UNIT


DESCRIPTION	a (width of atm opening)	b (height of atm opening)	c (ht of atm opening from fl)
NCR (CDM)SELF SERV 36	475mm	773mm	956mm
NCR (CDM)SELF SERV 87	680mm	1156mm	506mm
DN CINEO 4040 (2019)	530mm	1140mm	810mm

NOTE:
 VERIFY ATM UNIT PRIOR TO IMPLEMENTATION OF ATM OPENING

	<p>LANDBANK OF THE PHILIPPINES PROJECT MANAGEMENT & ENGINEERING DEPT. 1588 M.H. DEL PILAR ST. CORNER DR. QUIRICO ST. MALATE MANILA</p>	<p>CDM THRU THE WALL ACRYLIC FRAME PANEL SIGNAGE</p> <p style="font-size: small;">LANDBANK STANDARD DETAILED SPECIFICATIONS</p>	<p>APPROVED BY:</p> <p style="text-align: right;"><i>Enrico D.J. Samaniego</i> ENRICO D.J. SAMANIEGO HEAD, PMED</p>
<p>SHEET CONTENT</p> <p style="text-align: right;">DETAILS GENERAL NOTES</p>		<p>DESIGN: PMED-TSU</p> <p>DRAWN: MARION</p> <p>DATE: 15 NOVEMBER 2019</p> <p>CHECKED: J. MISLAN</p> <p>REV. DATE: 18 MAY 2019</p>	<p>SHEET NO.</p> <p style="font-size: large;">A-2</p> <p style="font-size: small;">1-SC-01</p>



PERSPECTIVE

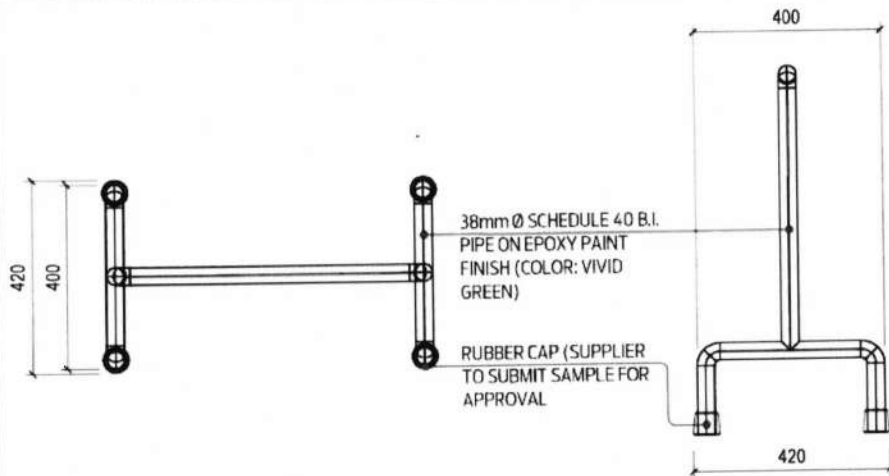


DETAILED PLAN

SCALE: 1:15 M

SIDE ELEVATION

SCALE: 1:15 M

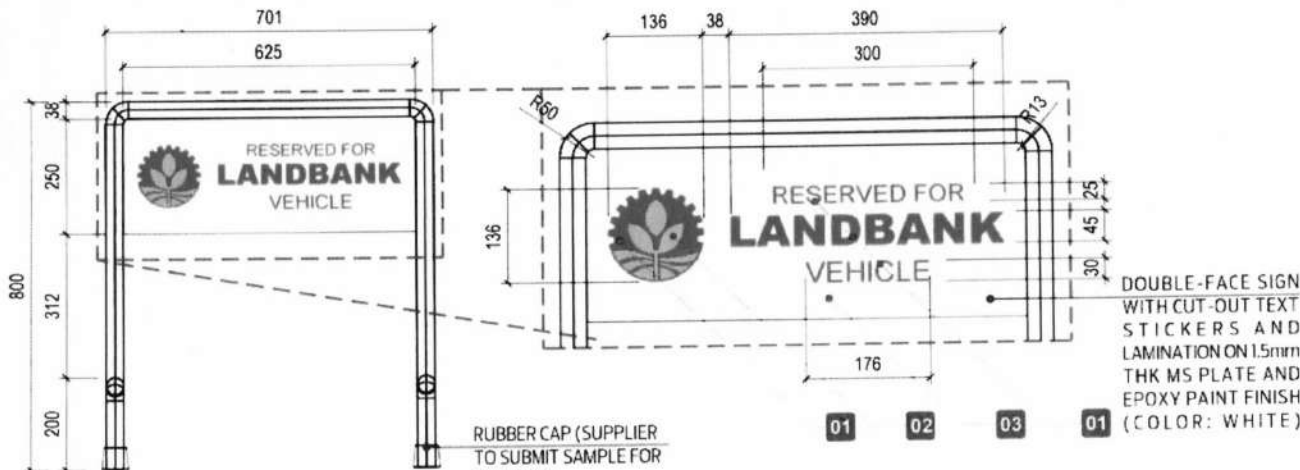

FRONT/ REAR ELEVATION

SCALE: 1:15 M

BLOW-UP DETAIL

SCALE: 1:10 M

TERMS OF REFERENCE:

CLASS D

1. SUPPLIER'S WARRANTY/ CERTIFICATION SHALL INCLUDE THE FOLLOWING:
A. 5 YEARS ON TRANSLUCENT FILM STICKER AGAINST DISCOLORATION/COLOR FADING AND STICKER ADHESION
B. 1 YEAR AGAINST ANY DEFECT IN PRODUCT OR WORKMANSHIP

(EXPENSES OF REPLACEMENT OR REPAIR OF THE ABOVE ITEMS WARRANTY SHALL BE SHOULDERS BY THE SUPPLIER)
2. SUPPLIER SHALL SUBMIT DETAILED DRAWINGS TO BE PRINTED ON AN A4 SIZE PAPER WITH THE SUPPLIER'S OFFICIAL LETTERHEAD AND SIGNED BY AN AUTHORIZED REPRESENTATIVE
3. SUPPLIER SHALL SUBMIT A PROTOTYPE/MOCK-UP UNIT, AS BASIS IN THE POST-QUALIFICATION EVALUATION
4. SUPPLIER SHALL VERIFY THE ACTUAL DIMENSIONS AND FINAL LOCATION FOR THE SIGNAGE. DISCREPANCIES BETWEEN THE PLANS AND ACTUAL DIMENSIONS SHALL BE FORWARDED IMMEDIATELY TO PMED FOR RESOLUTION.
5. ONCE BOTH THE PROTOTYPE IS APPROVED, SUPPLIER SHALL COORDINATE WITH THE END-USER FOR THE SCHEDULE OF MOBILIZATION/ DELIVERY OF THE SAID ITEM AND TO SECURE ANY CLEARANCES, IF ANY.
6. SUPPLIER SHALL SUBMIT (AS PART OF THE DOCUMENTARY REQUIREMENTS) TO PMED THE PHOTOS OF ACTUAL INSTALLATION ITEMS (CLOSE-UP AND DIFFERENT VIEWS OF THE SAID ITEM) FOR PROPER ISSUANCE OF CERTIFICATE OF SATISFACTORY PERFORMANCE.

GENERAL NOTES:

1. GRAPHICS CUTTING OF STICKER SHALL BE DONE WITH COMPUTER CUTTER (MANUAL CUTTING SHALL NOT BE ALLOWED NOR ACCEPTED).
2. INSTALLATION OF TRANSLUCENT FILM TO MS PLATE SHALL BE SEAMLESS WITH LAMINATION ON TOP OF TEXT.

C O L O R G U I D E

- 01 GREEN** - Pantone 355c or 3M Vivid Green (3530-156) or AVERY Forest Green (5560-QM) or approved equivalent
- 02 GOLD** - PANTONE No. 130 C or 3M Marigold (3530-75) or AVERY Golden Yellow (5510-01-QM) or approved equivalent
- 03 WHITE** - 3M White (3630-20) or AVERY White (5500-QM) or approved equivalent

F O N T T Y P E

LANDBANK - ARIAL BLACK

RESERVED FOR/VEHICLE - ARIAL



LAND BANK OF THE PHILIPPINES

PROJECT MANAGEMENT & ENGINEERING DEPT.

1598 M. H. DEL PILAR ST., CORNER DR. QUINTOS ST. MALATE MANILA

PROJECT TITLE:

PARKING DELINEATOR

LANDBANK STANDARD DETAILS AND SPECIFICATIONS

APPROVED BY:

Enrico D. Samaniego
ENRICO D.J. SAMANIEGO

HEAD, PMED

SHEET NO:

PERSPECTIVE
DETAILED PLAN
SIDE ELEVATION
FRONT/REAR ELEVATION
BLOW-UP DETAIL
COLOR GUIDE
FONT TYPE

DESIGN:

TSU-PMED

DRAWN BY:

A. EBORA

DATE:

12/10/21

CHECKED:

M. PADUA

REVIEWED BY:

J. M. ANG

SHEET NO:

A-1

1-PD-01

Revised Annex D-1B